



SEALS / SIGNATURES:

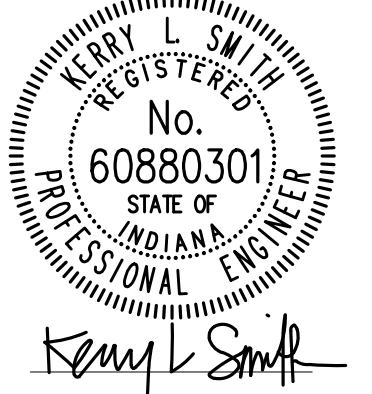

CONSULTANTS:

Mechanical / Electrical / Plumbing
Engineer:

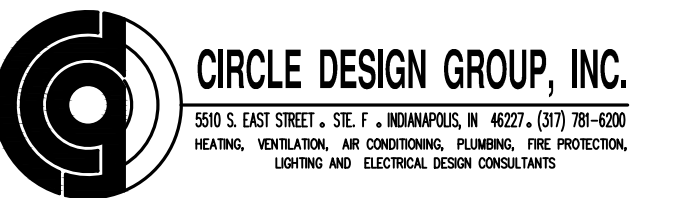

Structural Engineer:



PROJECT

IUPUI
INDIANA UNIVERSITY
PURDUE UNIVERSITY
INDIANAPOLIS

**CAVANAUGH
HALL**

**RESTROOM RENOVATION
PHASE 2**

425 University Boulevard
Indianapolis, IN 46202

PROJECT NUMBER

IU #20141189
CDG #13045A

DATE / ISSUE

02-18-15 95% CONSTRUCTION DOCUMENTS
OWNER REVIEW ISSUE


03-13-15 CONSTRUCTION DOCUMENTS

SHEET NAME

BASEMENT FLOOR PLANS -
PLUMBING
DEMOLITION



SHEET NUMBER

PD200

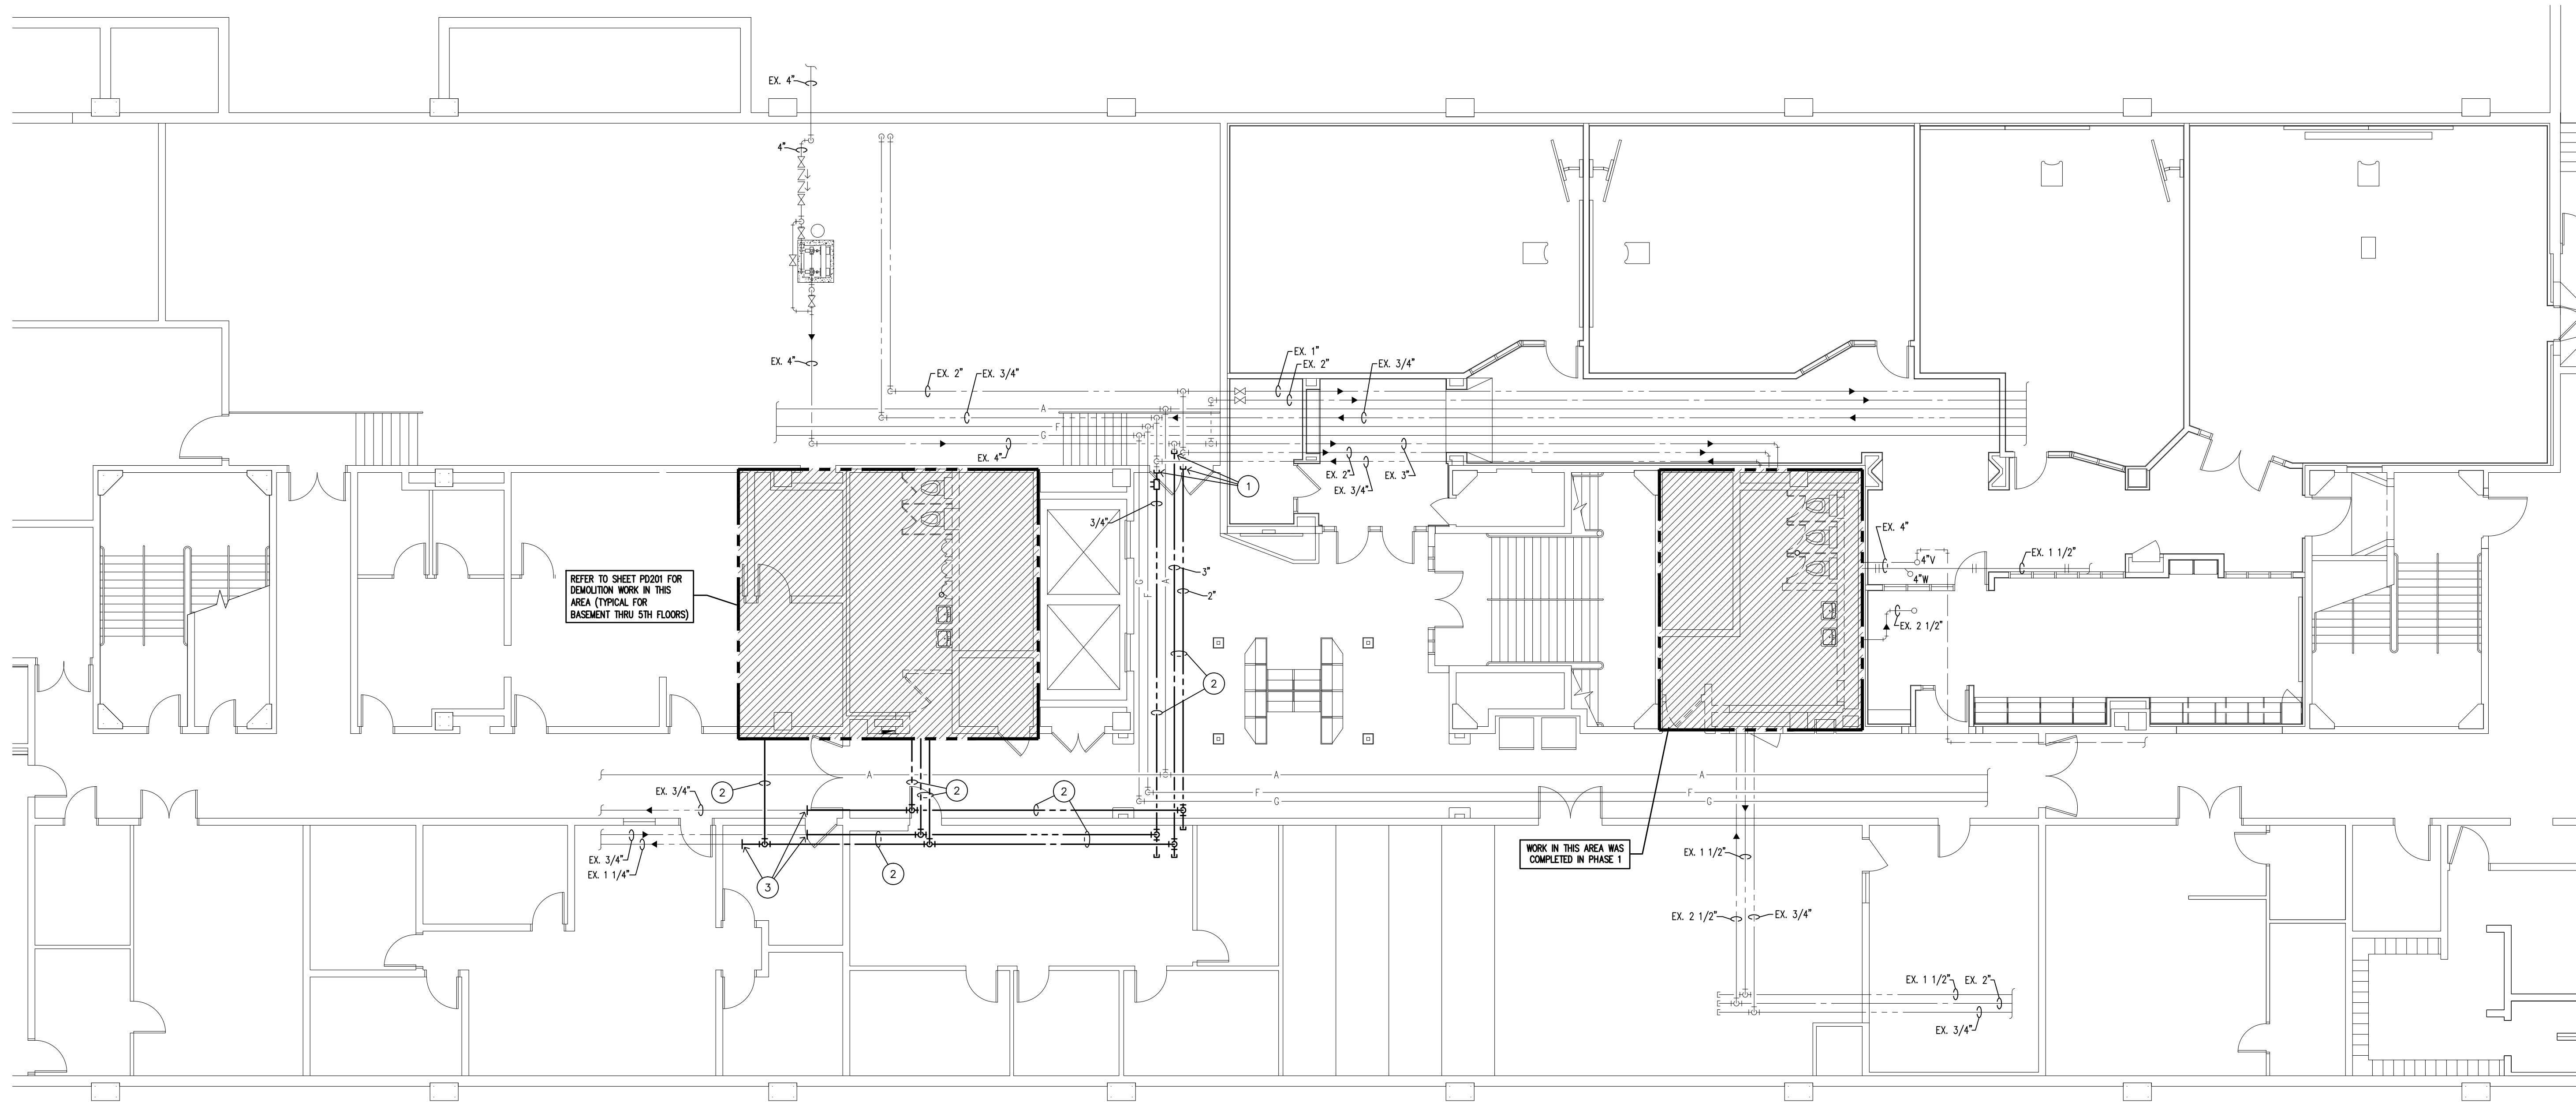


BASEMENT FLOOR PLAN (ALTERNATE BID) - PLUMBING DEMOLITION

SCALE: 1/8" = 1'-0"

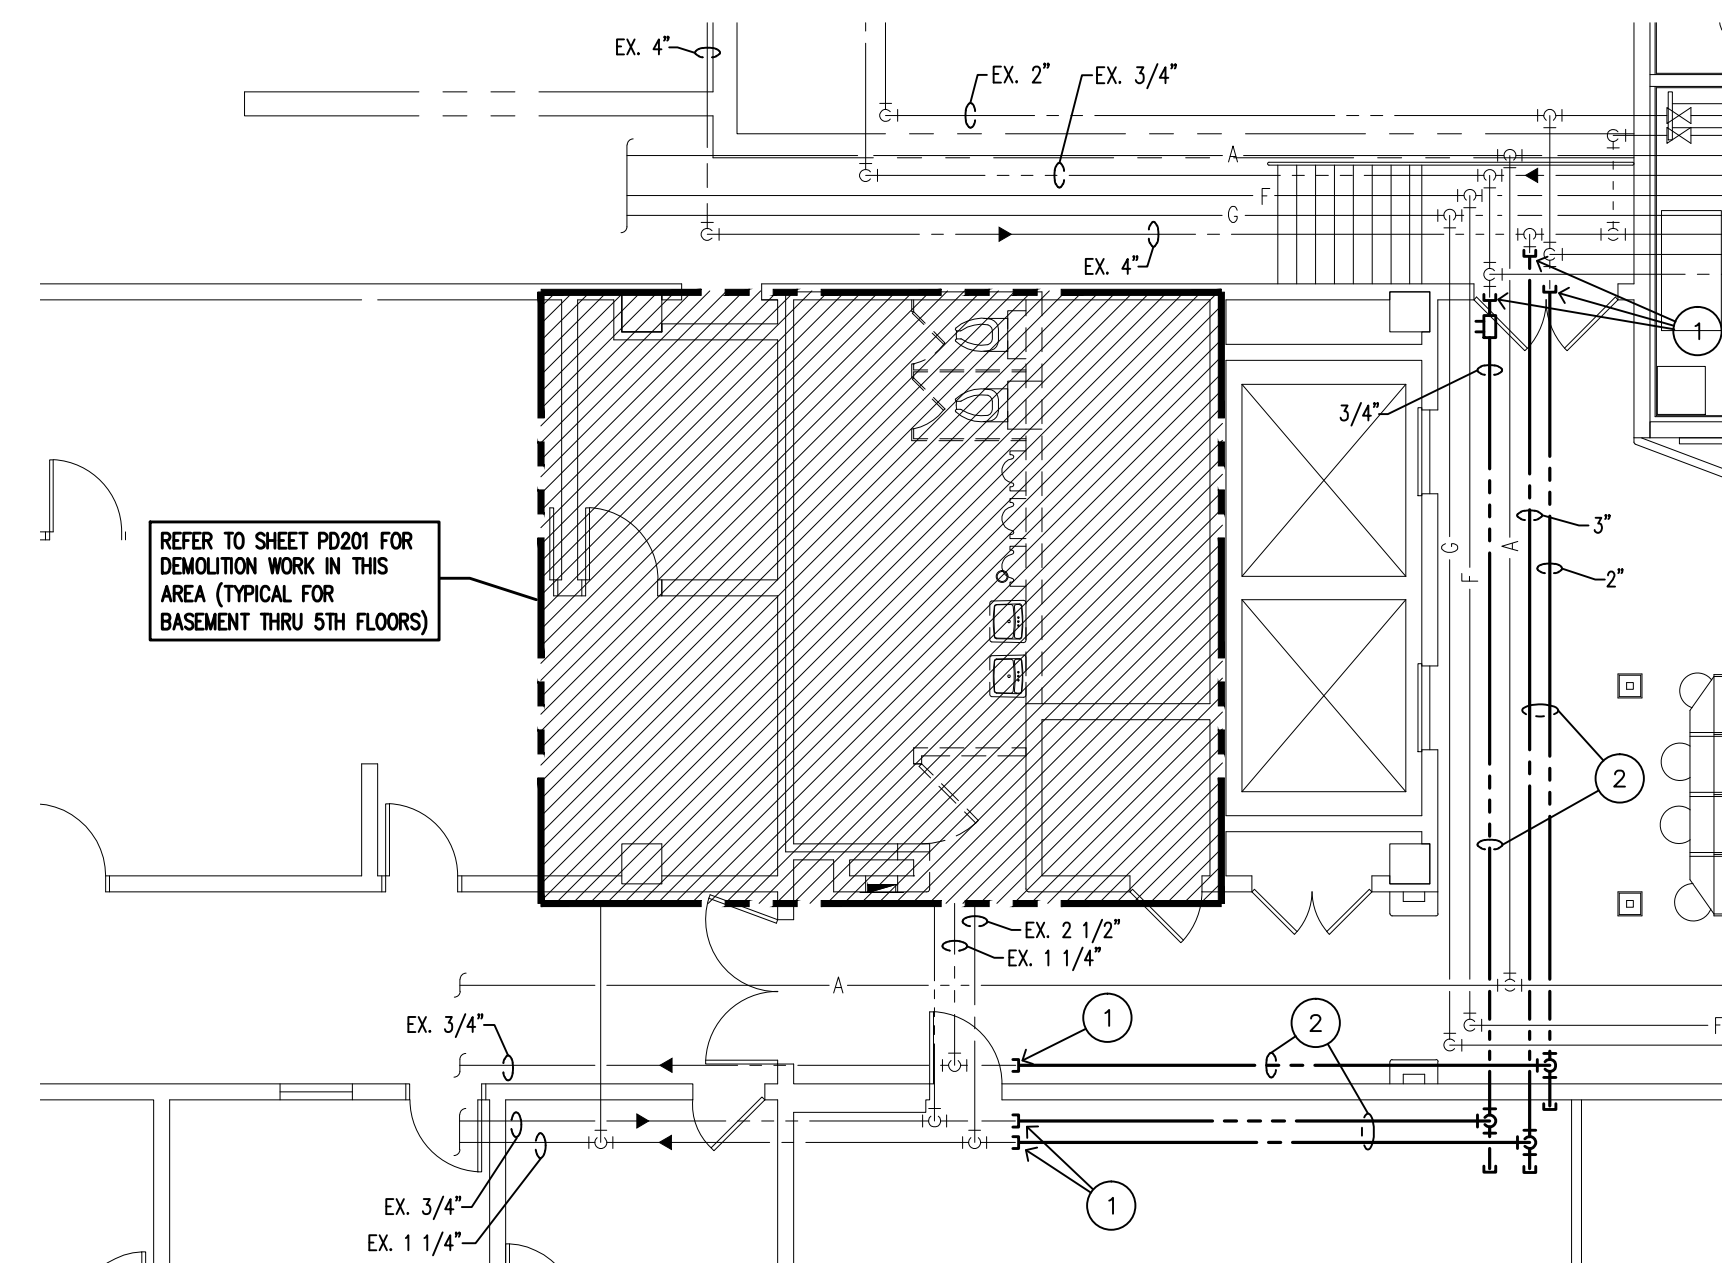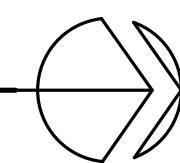

PARTIAL BASEMENT FLOOR PLAN (BASE BID) - PLUMBING DEMOLITION

SCALE: 1/8" = 1'-0"

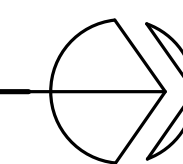

PLAN NOTES:

- 1 REMOVE PIPING BACK TO POINT INDICATED AND CAP.
- 2 REMOVE PIPING AND VALVES COMPLETE.
- 3 REMOVE PIPING BACK TO POINT INDICATED AND PREPARE FOR RECONNECTION.